

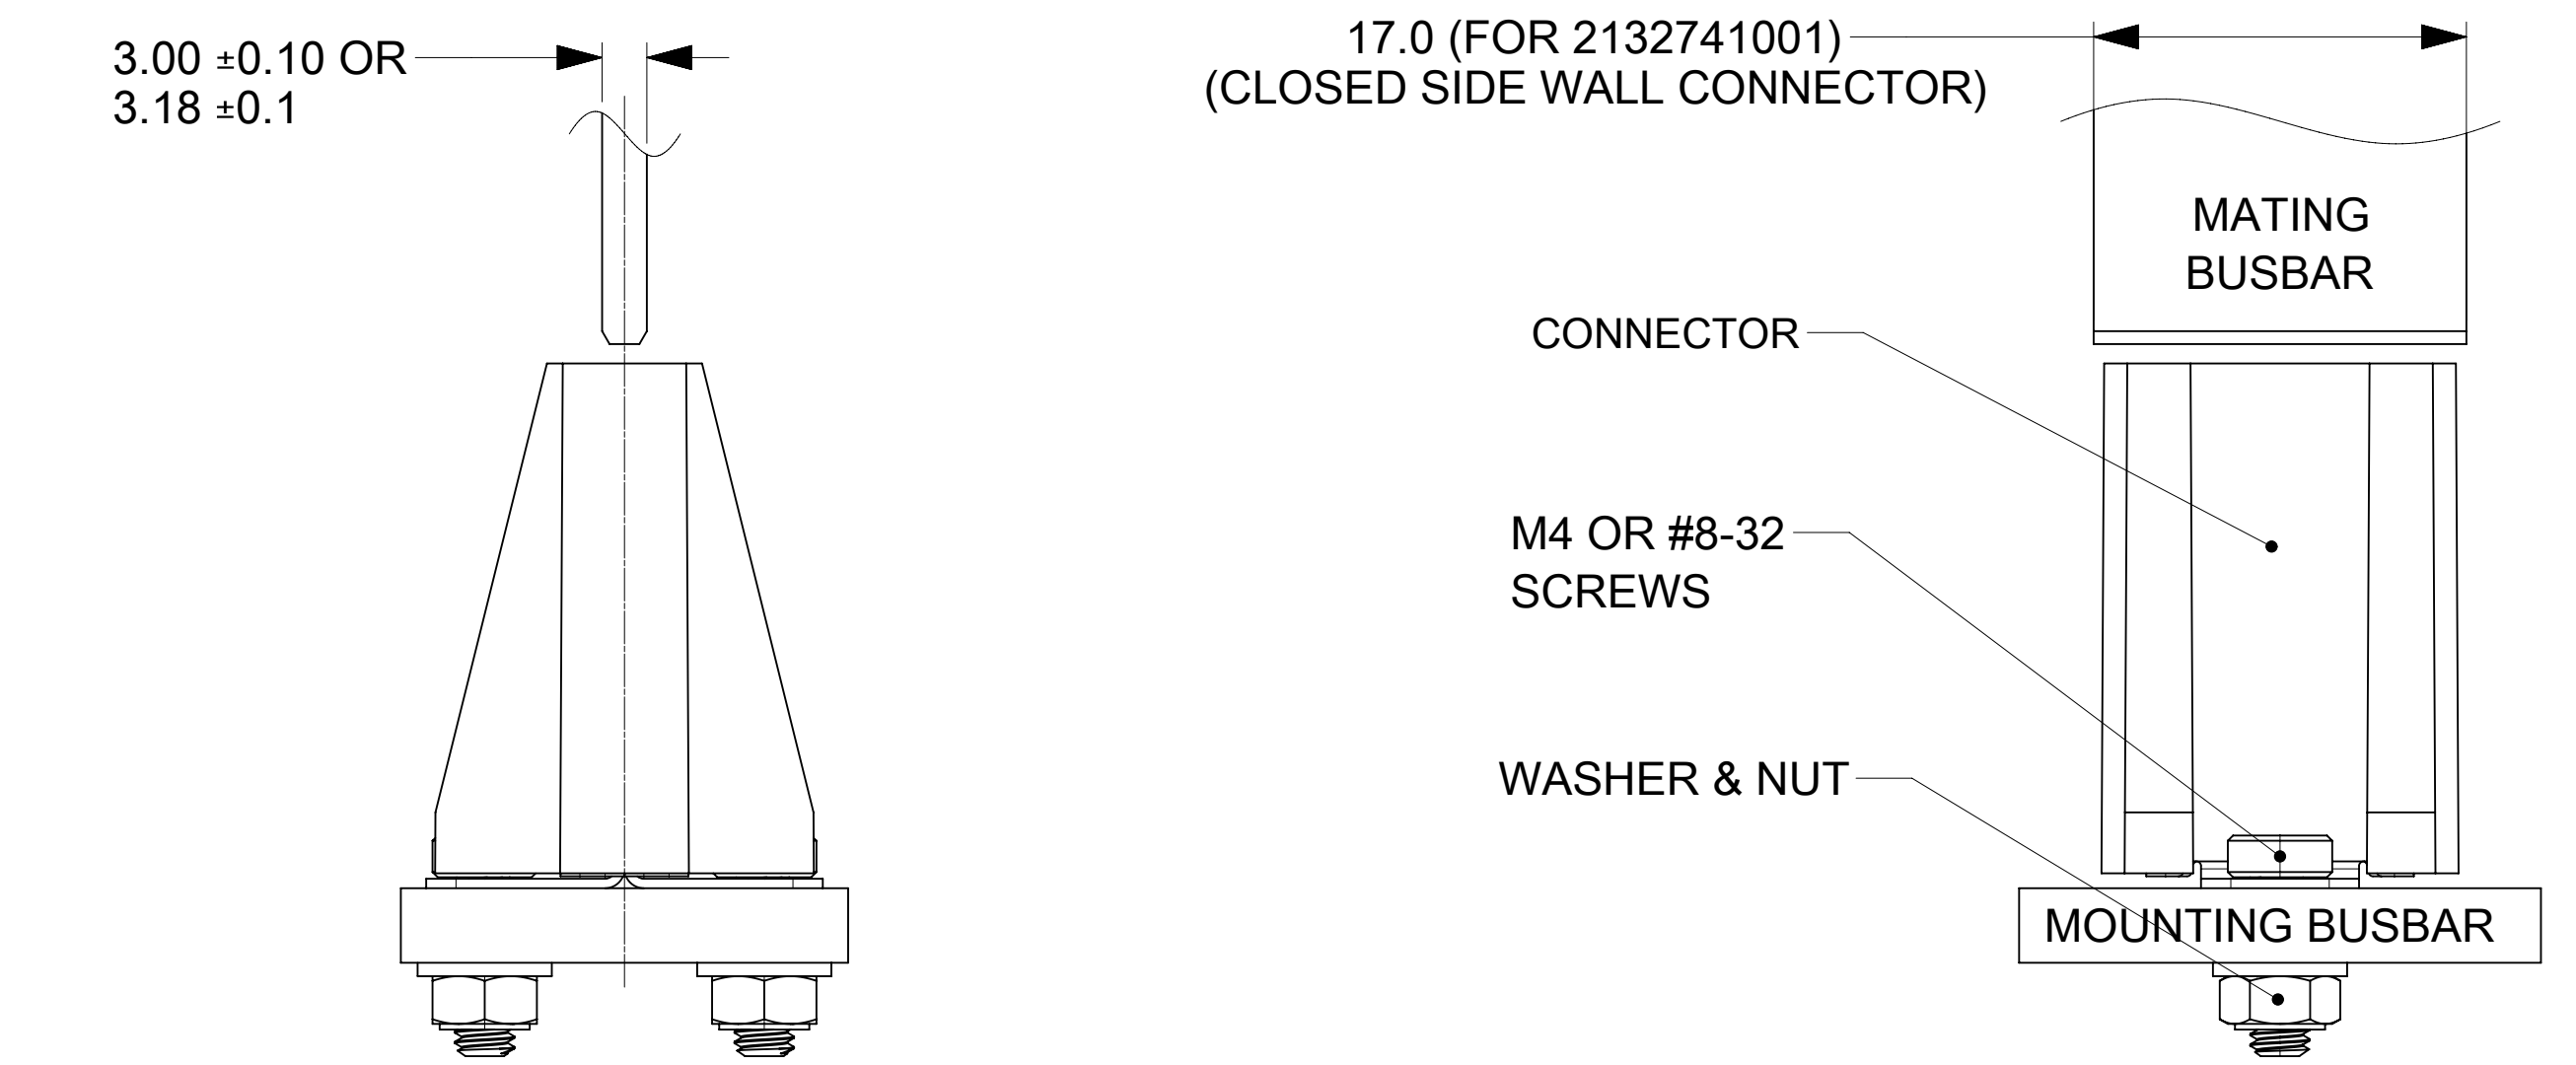


PART NUMBER	DESCRIPTION	NOTE
2132740001	OPEN SIDE WALL	
2132741001	CLOSED SIDE WALL	



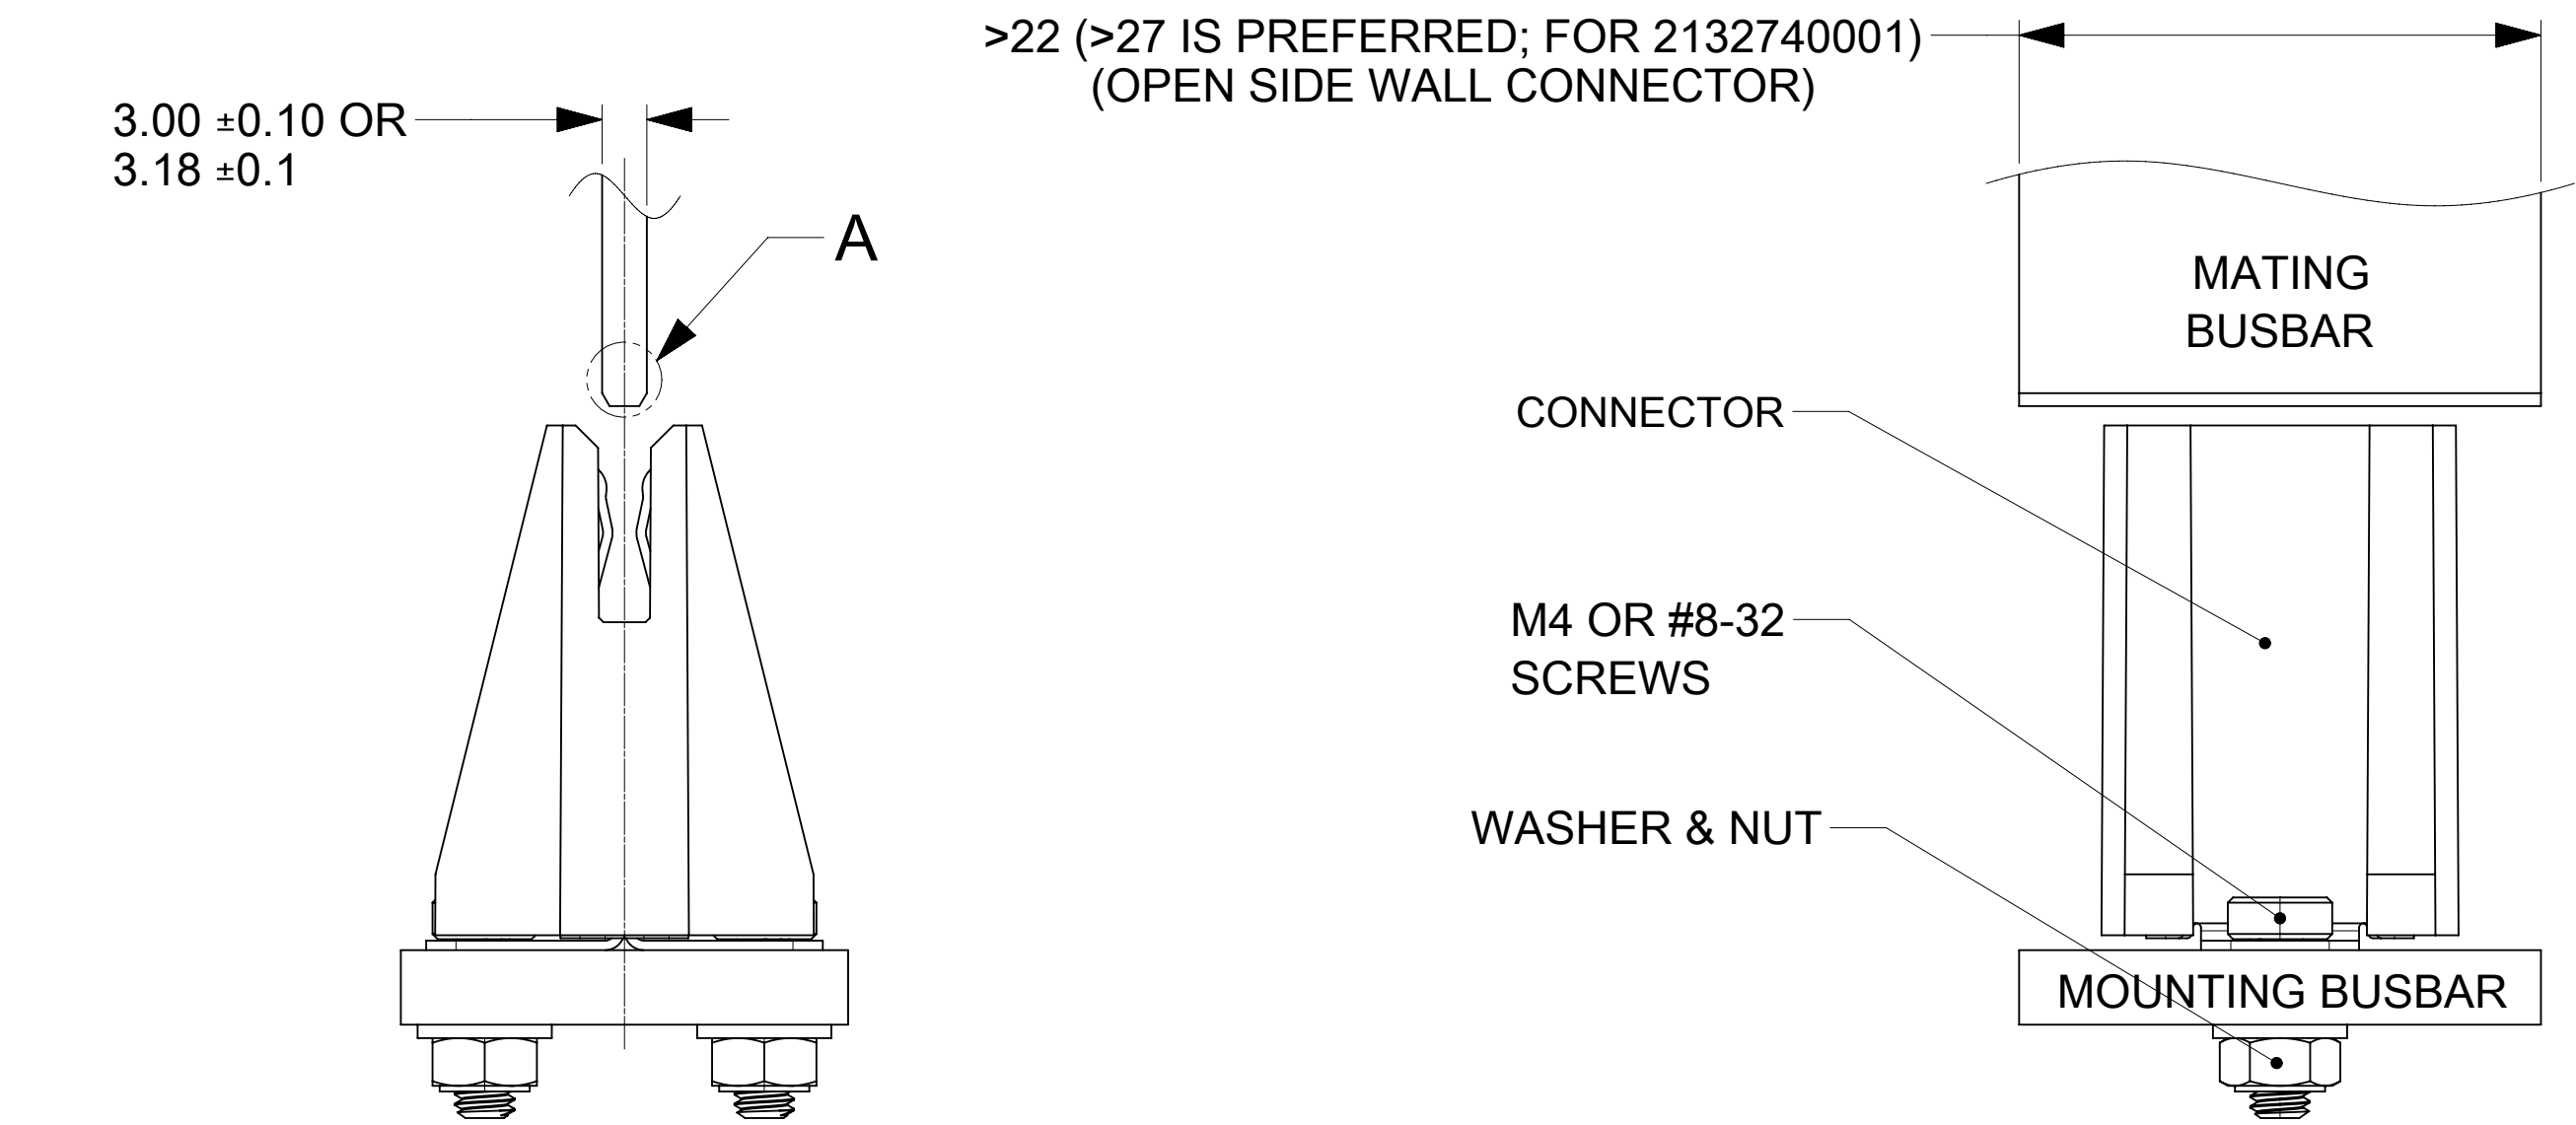


BUSBARS, SCREWS, WASHER AND NUTS
IN THESE VIEWS ARE SHOWN FOR REFERENCE

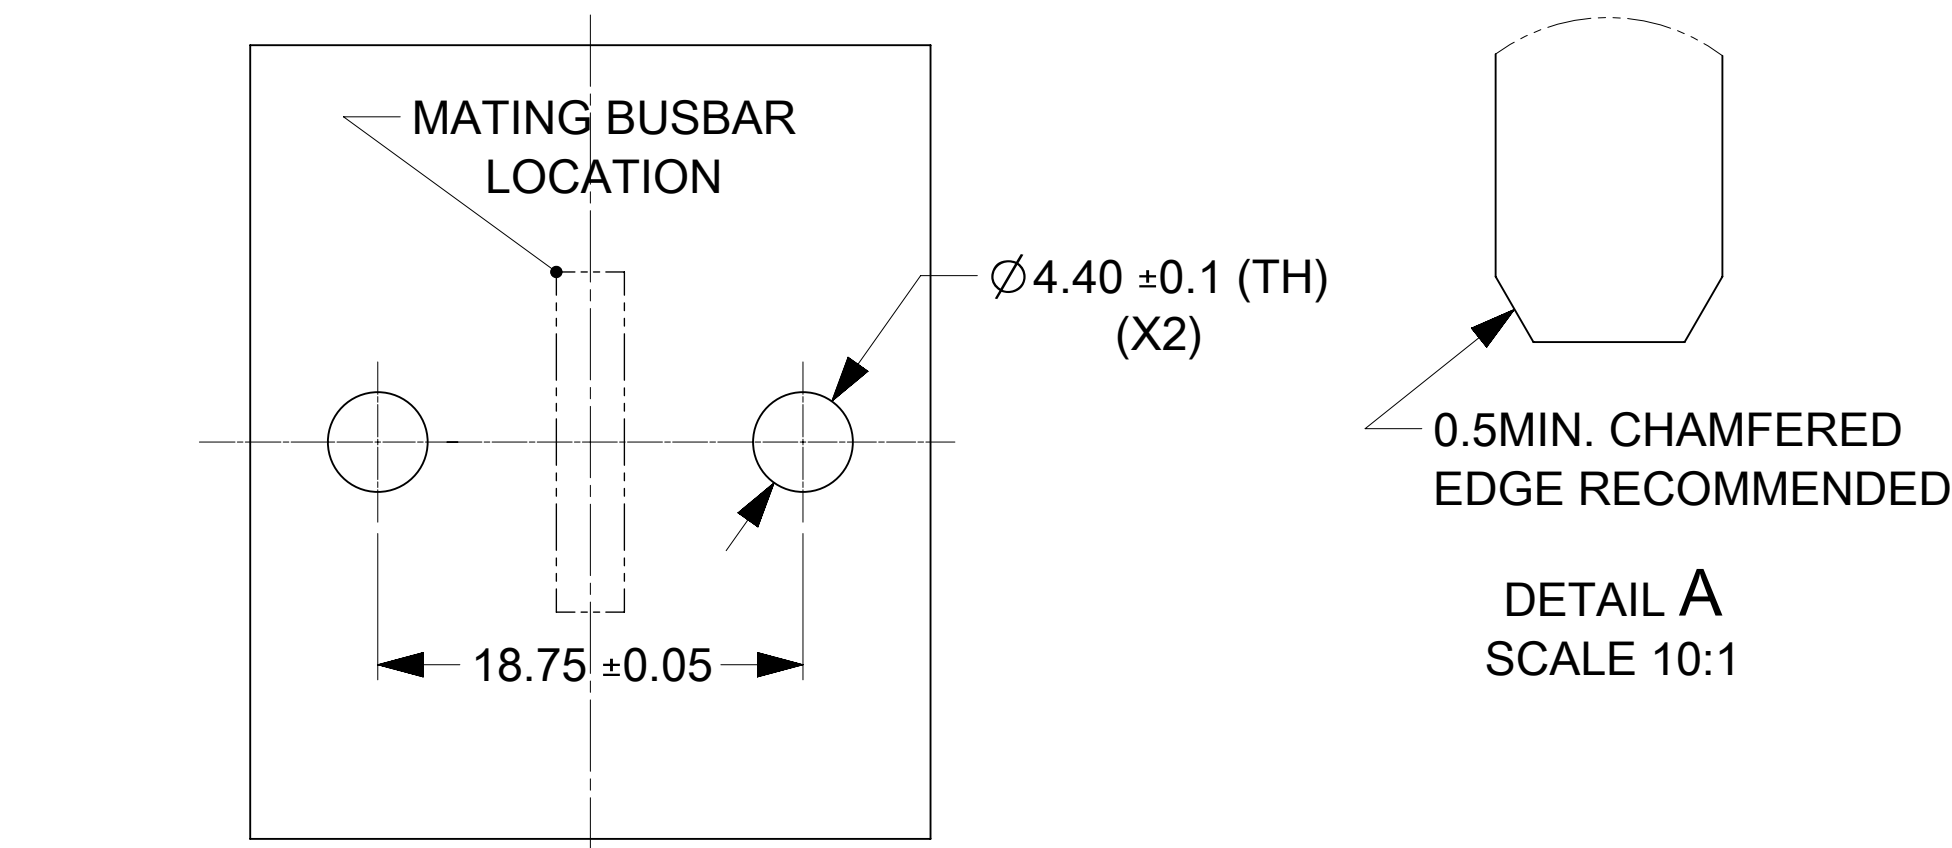


RECOMMENDED BUSBAR LAYOUT

- NOTES:
- MATERIALS:
 - HOUSING BODY: POLYMER, UL94V-0, BLACK.
 - TERMINALS: COPPER ALLOY.
 - RIVET/CLIP: COPPER ALLOY.
 - PLATING:
 - CONTACT AREAS: 3.18 MICRON MIN. SILVER, OVER 1.27 MICRON MIN. NICKEL.
 - TAB AREAS: 3.18 MICRON MIN. TIN OVER 1.27 MICRON MIN. NICKEL.
 - REST: 1.27 MICRON MIN. NICKEL.
 - LUBRICATION: LUBED IN CONTACT AREA.
 - REFERENCE DOCUMENT: 2132740001-PS, 2132740001-AS
 - MODULE ASSEMBLY IS RoHS COMPLIANT.
 - FINAL ASSEMBLY TO BE PACKAGED AND LABELED PER PACKAGING KIT DRAWING NUMBER 2132740001-PK.

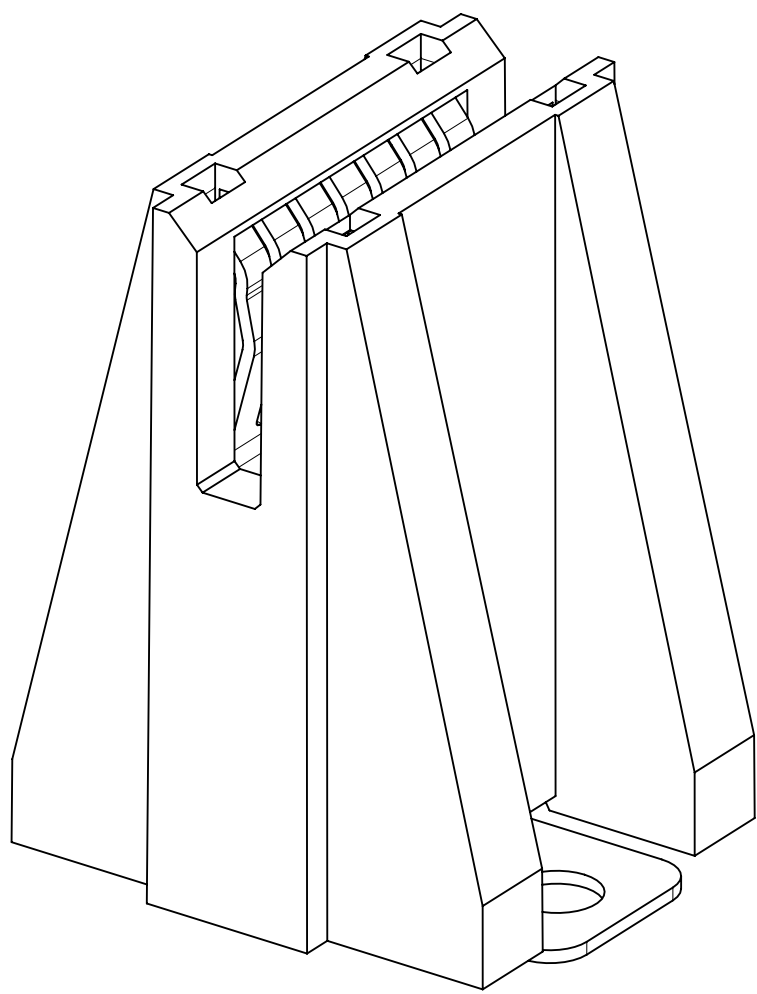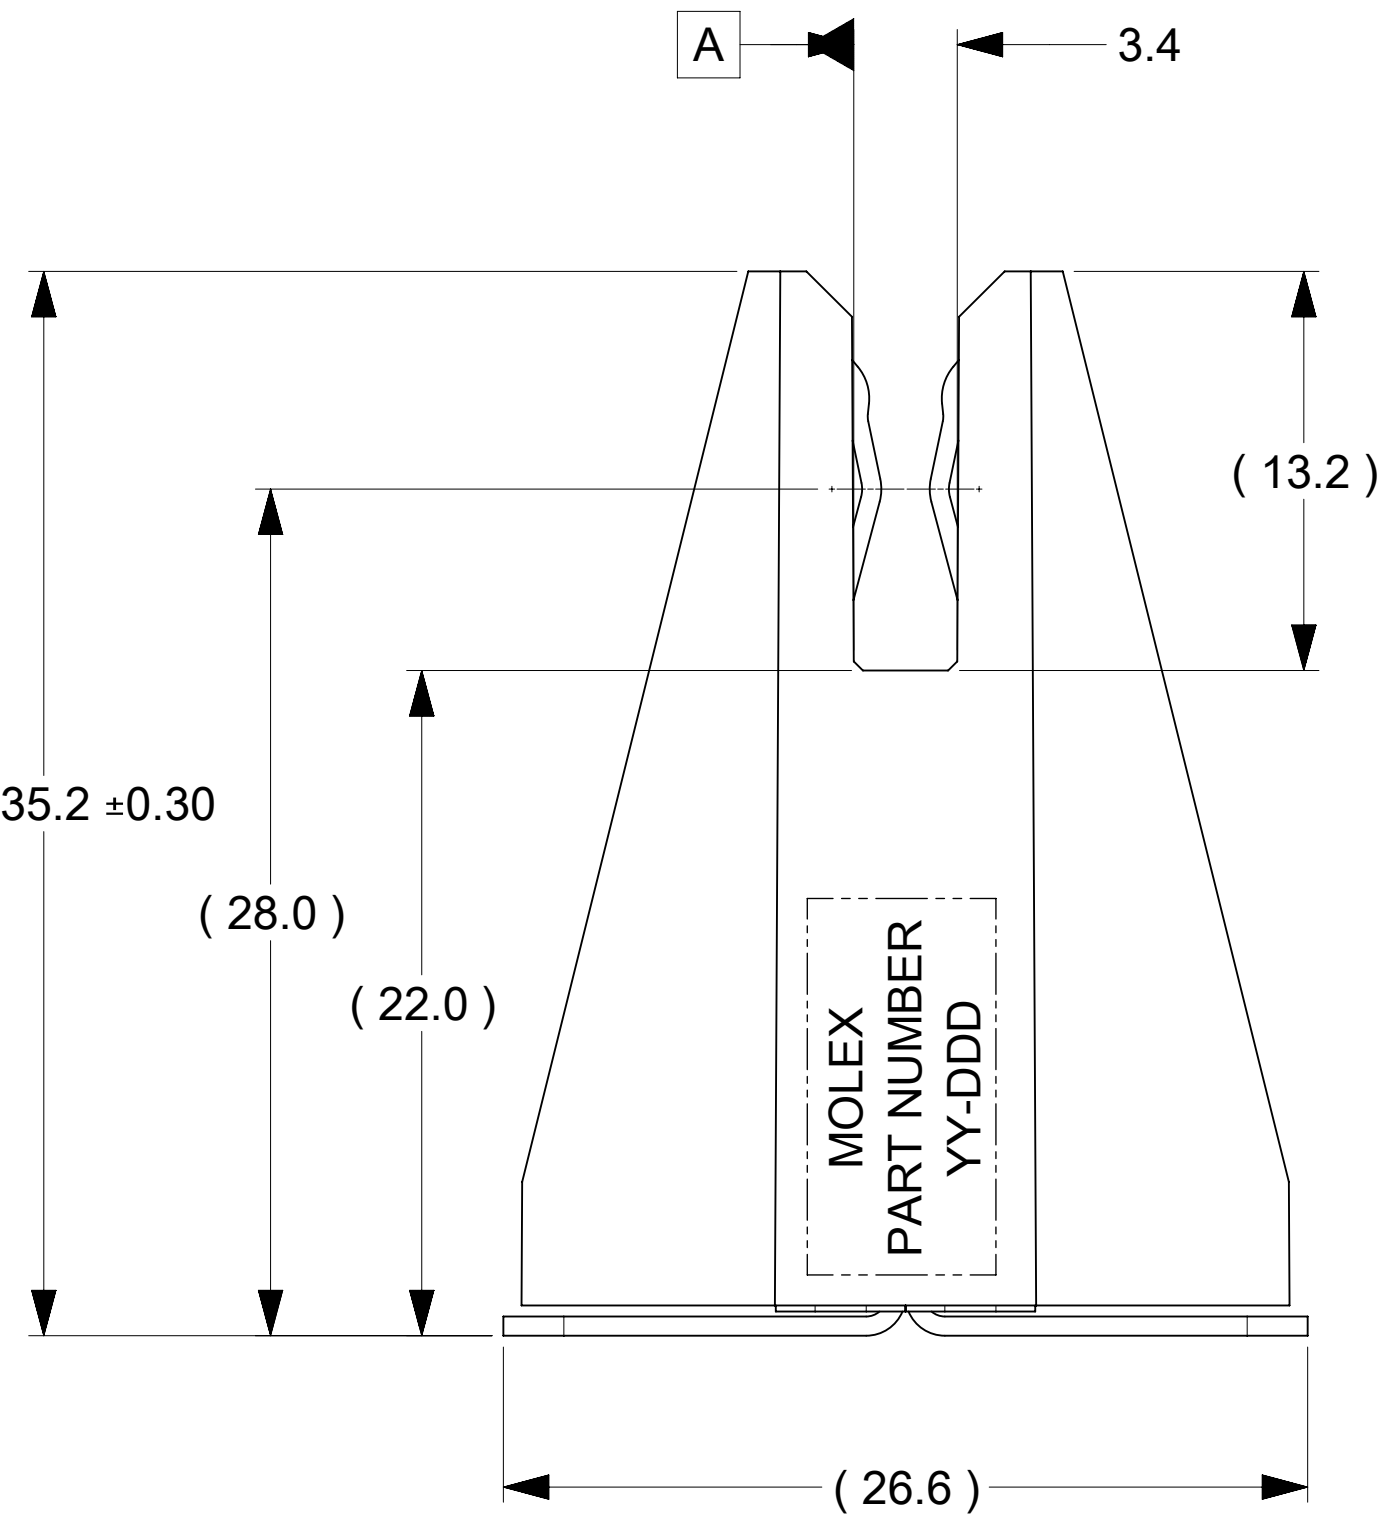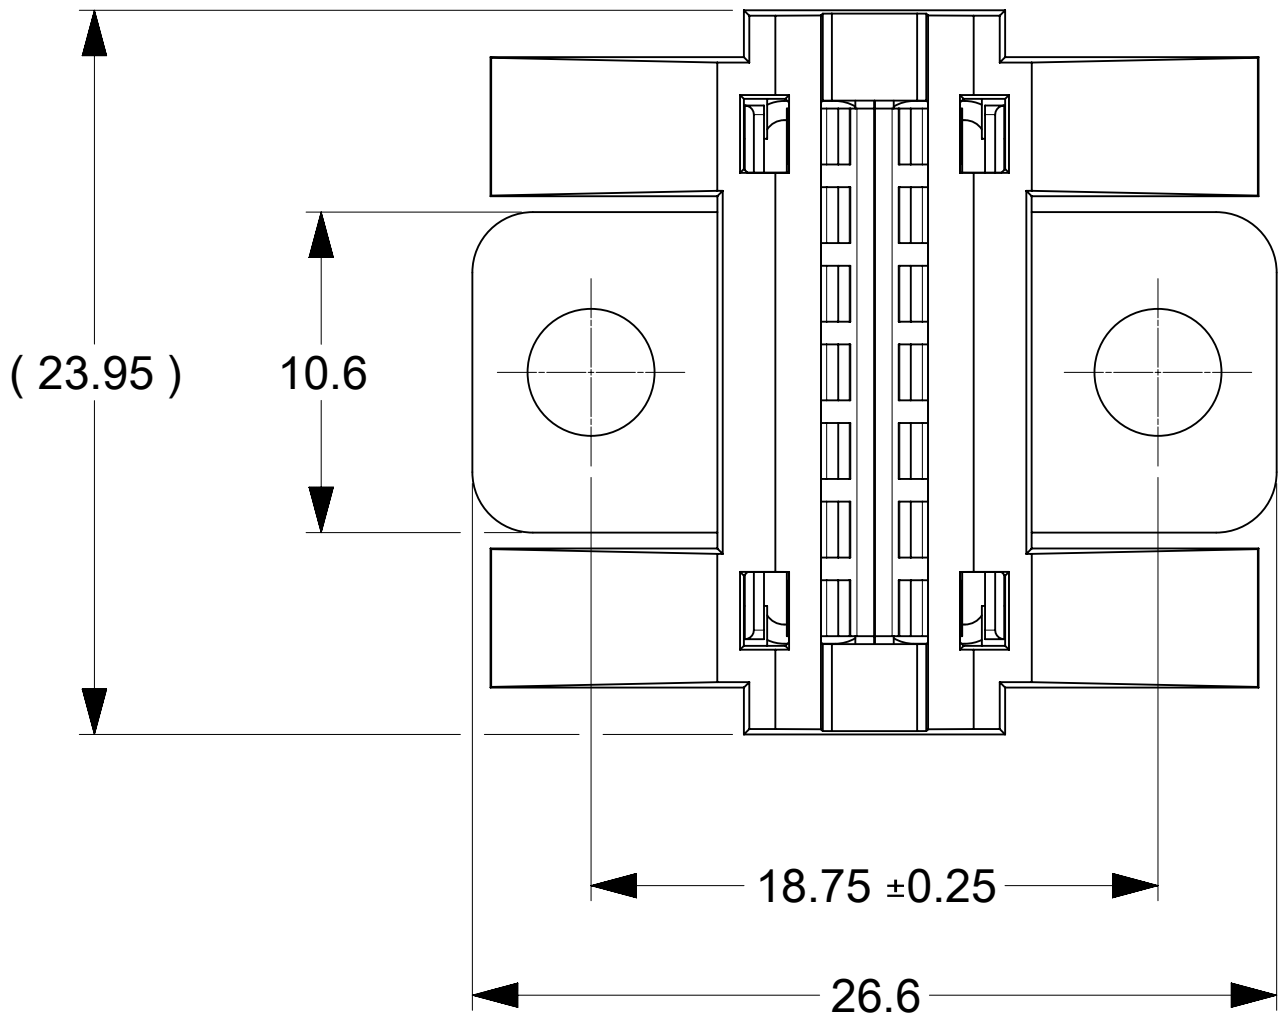

PART NUMBER: 2132740001
(OPEN SIDE WALLS)

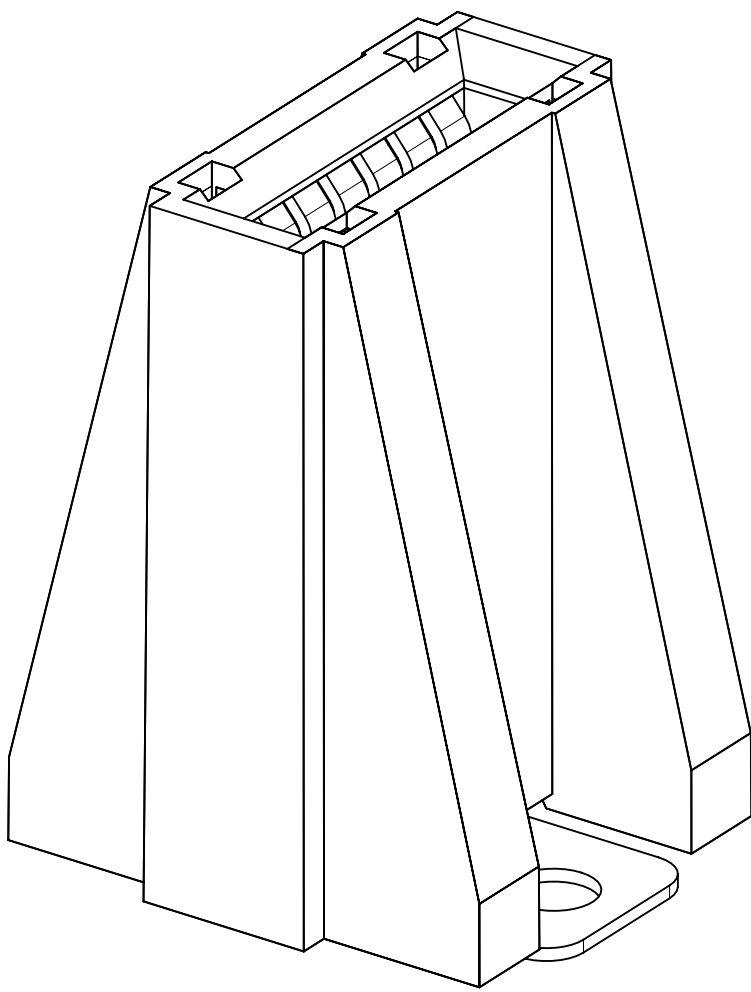

PART NUMBER: 2132741001
(CLOSED SIDE WALLS)

THIS DRAWING CONTAINS INFORMATION THAT IS PROPRIETARY TO MOLEX ELECTRONIC TECHNOLOGIES, LLC AND SHOULD NOT BE USED WITHOUT WRITTEN PERMISSION										
DIMENSION UNITS		SCALE		CURRENT REV DESC:						
mm		3:1								
GENERAL TOLERANCES (UNLESS SPECIFIED)				EC NO: 691460 DRWN: TOMLU 2022/02/24 CHK'D: BPISZCZOR 2022/03/09 APPR: BPISZCZOR 2022/03/09 INITIAL REVISION: DRWN: TOMLU 2021/06/22 APPR: BPISZCZOR 2022/03/09						
ANGULAR TOL		±	°							
4 PLACES		±								
3 PLACES		±								
2 PLACES		±	0.15							
1 PLACE		±	0.25							
0 PLACES		±								
DRAFT WHERE APPLICABLE MUST REMAIN WITHIN DIMENSIONS				THIRD ANGLE PROJECTION 		DRAWING D-SIZE	SERIES 213274	MATERIAL NUMBER SEE CHART	CUSTOMER	SHEET NUMBER 1 OF 1

POWER PLANE BBC 7C VERTICAL			
PRODUCT CUSTOMER DRAWING			
DOCUMENT NUMBER	DOC TYPE	DOC PART	REVISION
2132740001-SD	PSD	000	A